
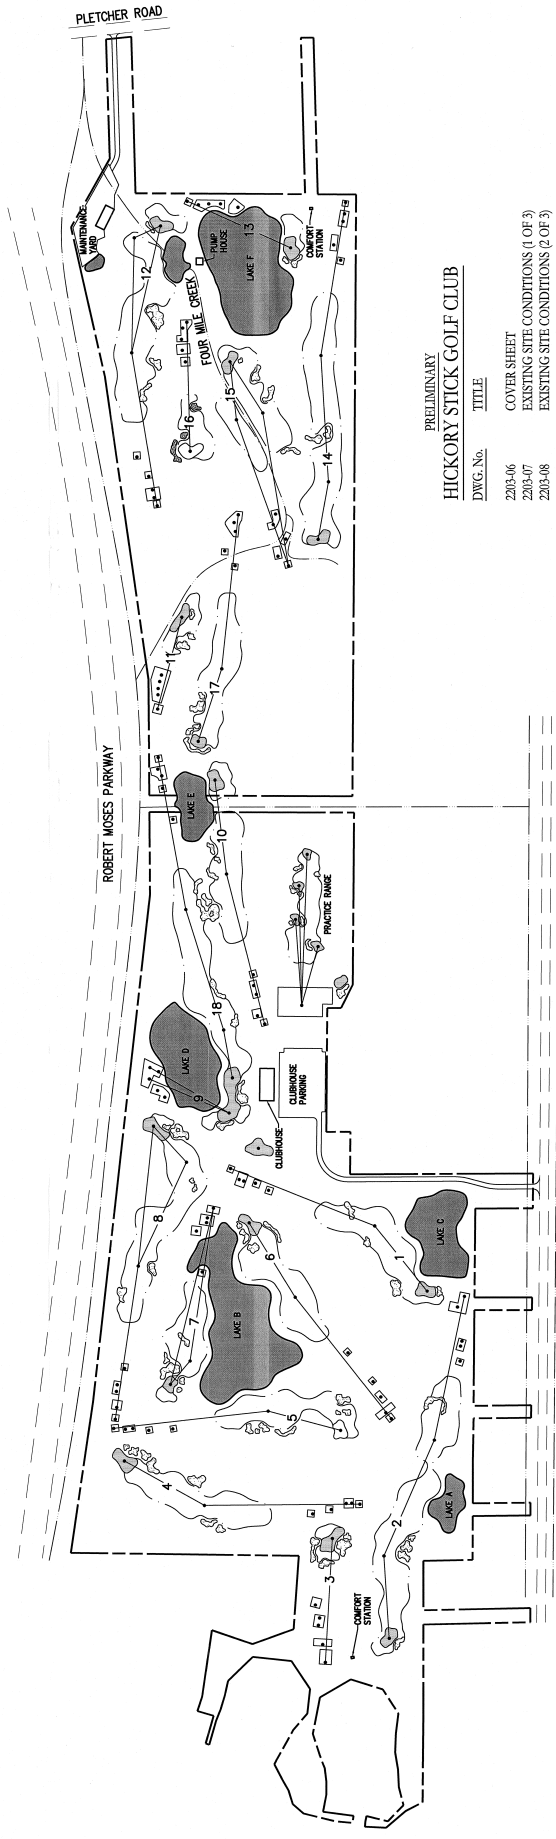


# PRELIMINARY PLANS

# HICKORY STICK GOLF CLUB

TOWN OF LEWISTON, NIAGARA COUNTY, NEW YORK

## EXHIBIT A

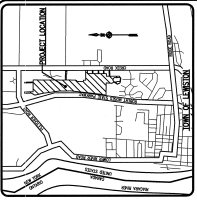

### PRELIMINARY HICKORY STICK GOLF CLUB

DWG. No.	TITLE
2015-06	COVER SHEET
2015-07	EXISTING SITE CONDITIONS (1 OF 3)
2015-08	EXISTING SITE CONDITIONS (2 OF 3)
2015-09	EXISTING SITE CONDITIONS (3 OF 3)
2015-10	GOLF COURSE ROUTING PLAN (1 OF 3)
2015-11	GOLF COURSE ROUTING PLAN (2 OF 3)
2015-12	GOLF COURSE ROUTING PLAN (3 OF 3)
2015-13	UTILITY PLAN (1 OF 3)
2015-14	UTILITY PLAN (2 OF 3)
2015-15	UTILITY PLAN (3 OF 3)
2015-16	GRADING PLAN (1 OF 3)
2015-17	GRADING PLAN (2 OF 3)
2015-18	GRADING PLAN (3 OF 3)
2015-19	CONSTRUCTION EROSION CONTROL PLAN (1 OF 3)
2015-20	CONSTRUCTION EROSION CONTROL PLAN (2 OF 3)
2015-21	CONSTRUCTION EROSION CONTROL PLAN (3 OF 3)
2015-22	CLUBHOUSE SITE, LANDSCAPE AND LIGHTING PLAN
2015-23	CLUBHOUSE GRADING AND UTILITY PLAN
2015-24	MAINTENANCE YARD SITE, LANDSCAPE AND LIGHTING PLAN
2015-25	MAINTENANCE YARD GRADING AND LIGHTING PLAN
2015-26	DETAIL SHEET (1 OF 3)
2015-27	DETAIL SHEET (2 OF 3)
2015-28	DETAIL SHEET (3 OF 3)

PREPARED FOR:  
 SENECA MANAGEMENT DEVELOPMENT CORPORATION  
 310 FOURTH STREET  
 NIAGARA FALLS, NY 14303

**BME**  
 ASSOCIATES  
 LANDSCAPE ARCHITECTS, PLANNERS  
 15 LAFAYETTE SQUARE  
 NIAGARA FALLS, NY 14303  
 TEL: 716.285.1400  
 FAX: 716.285.1400  
 WWW.BME-ASSOCIATES.COM

**TRENTIONES**  
 ARCHITECTS  
 15 LAFAYETTE SQUARE  
 NIAGARA FALLS, NY 14303  
 TEL: 716.285.1400  
 FAX: 716.285.1400  
 WWW.TRENTIONES.COM

DATE: 1-2016    EXPIRES: 2016